


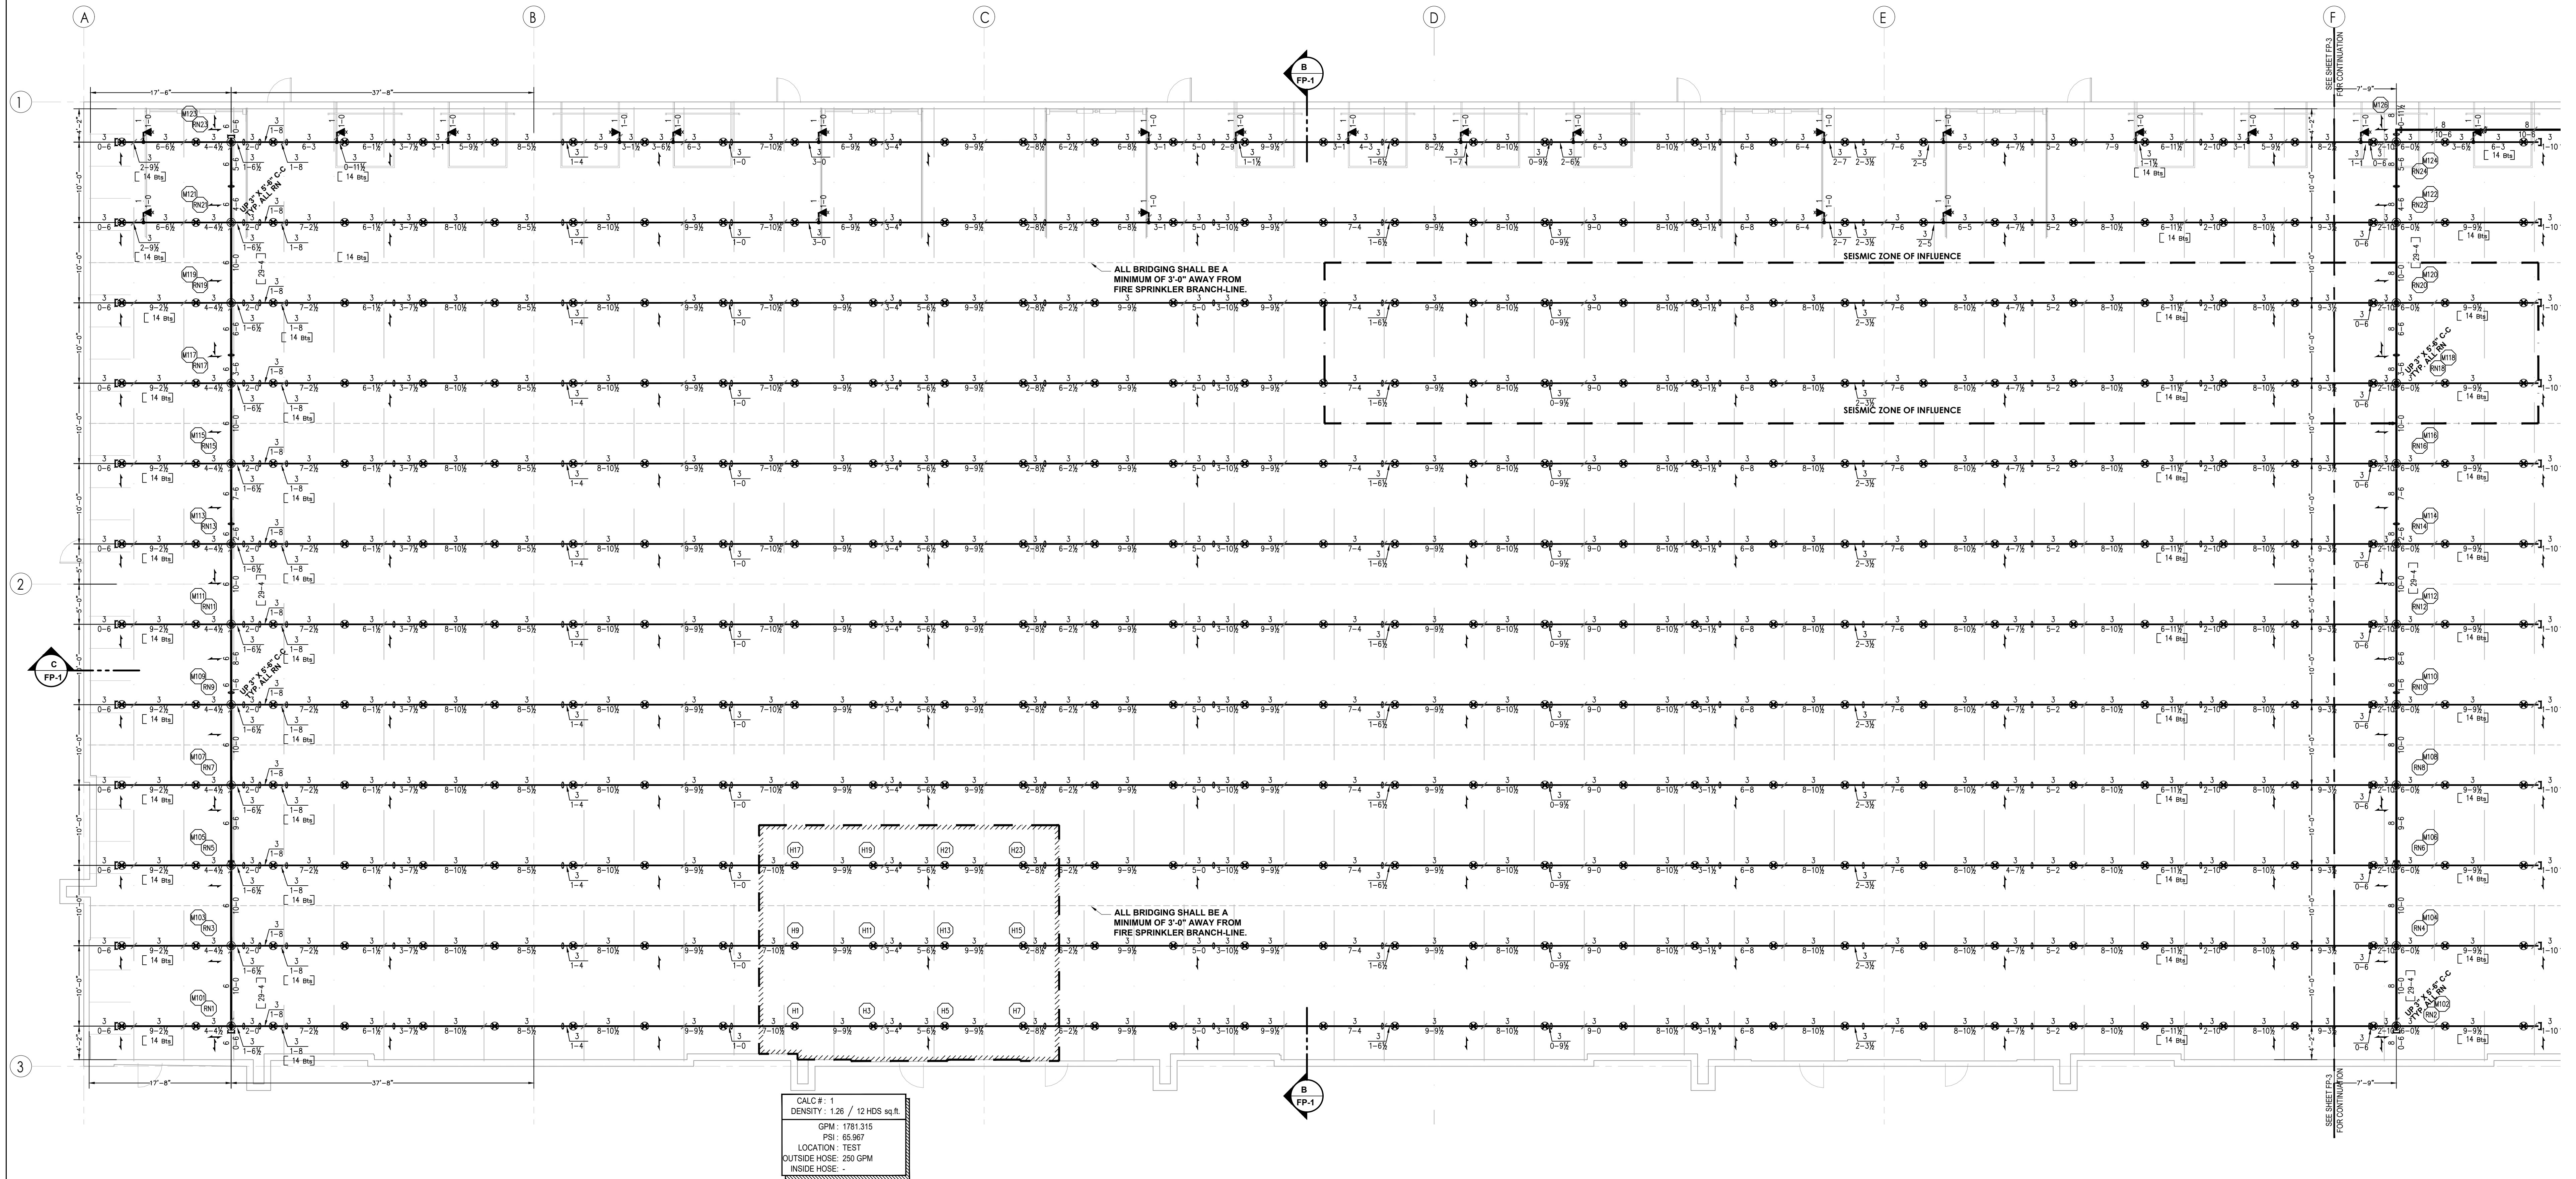



BUILDING - 1 - AREA "A" - SYSTEM 1 - FIRE PROTECTION PLAN
SCALE: 1/8" = 1'-0"

SYSTEM 1 - AREA "A"


SYSTEM 2 - AREA "B"

KEY PLAN
SCALE: N.T.S.

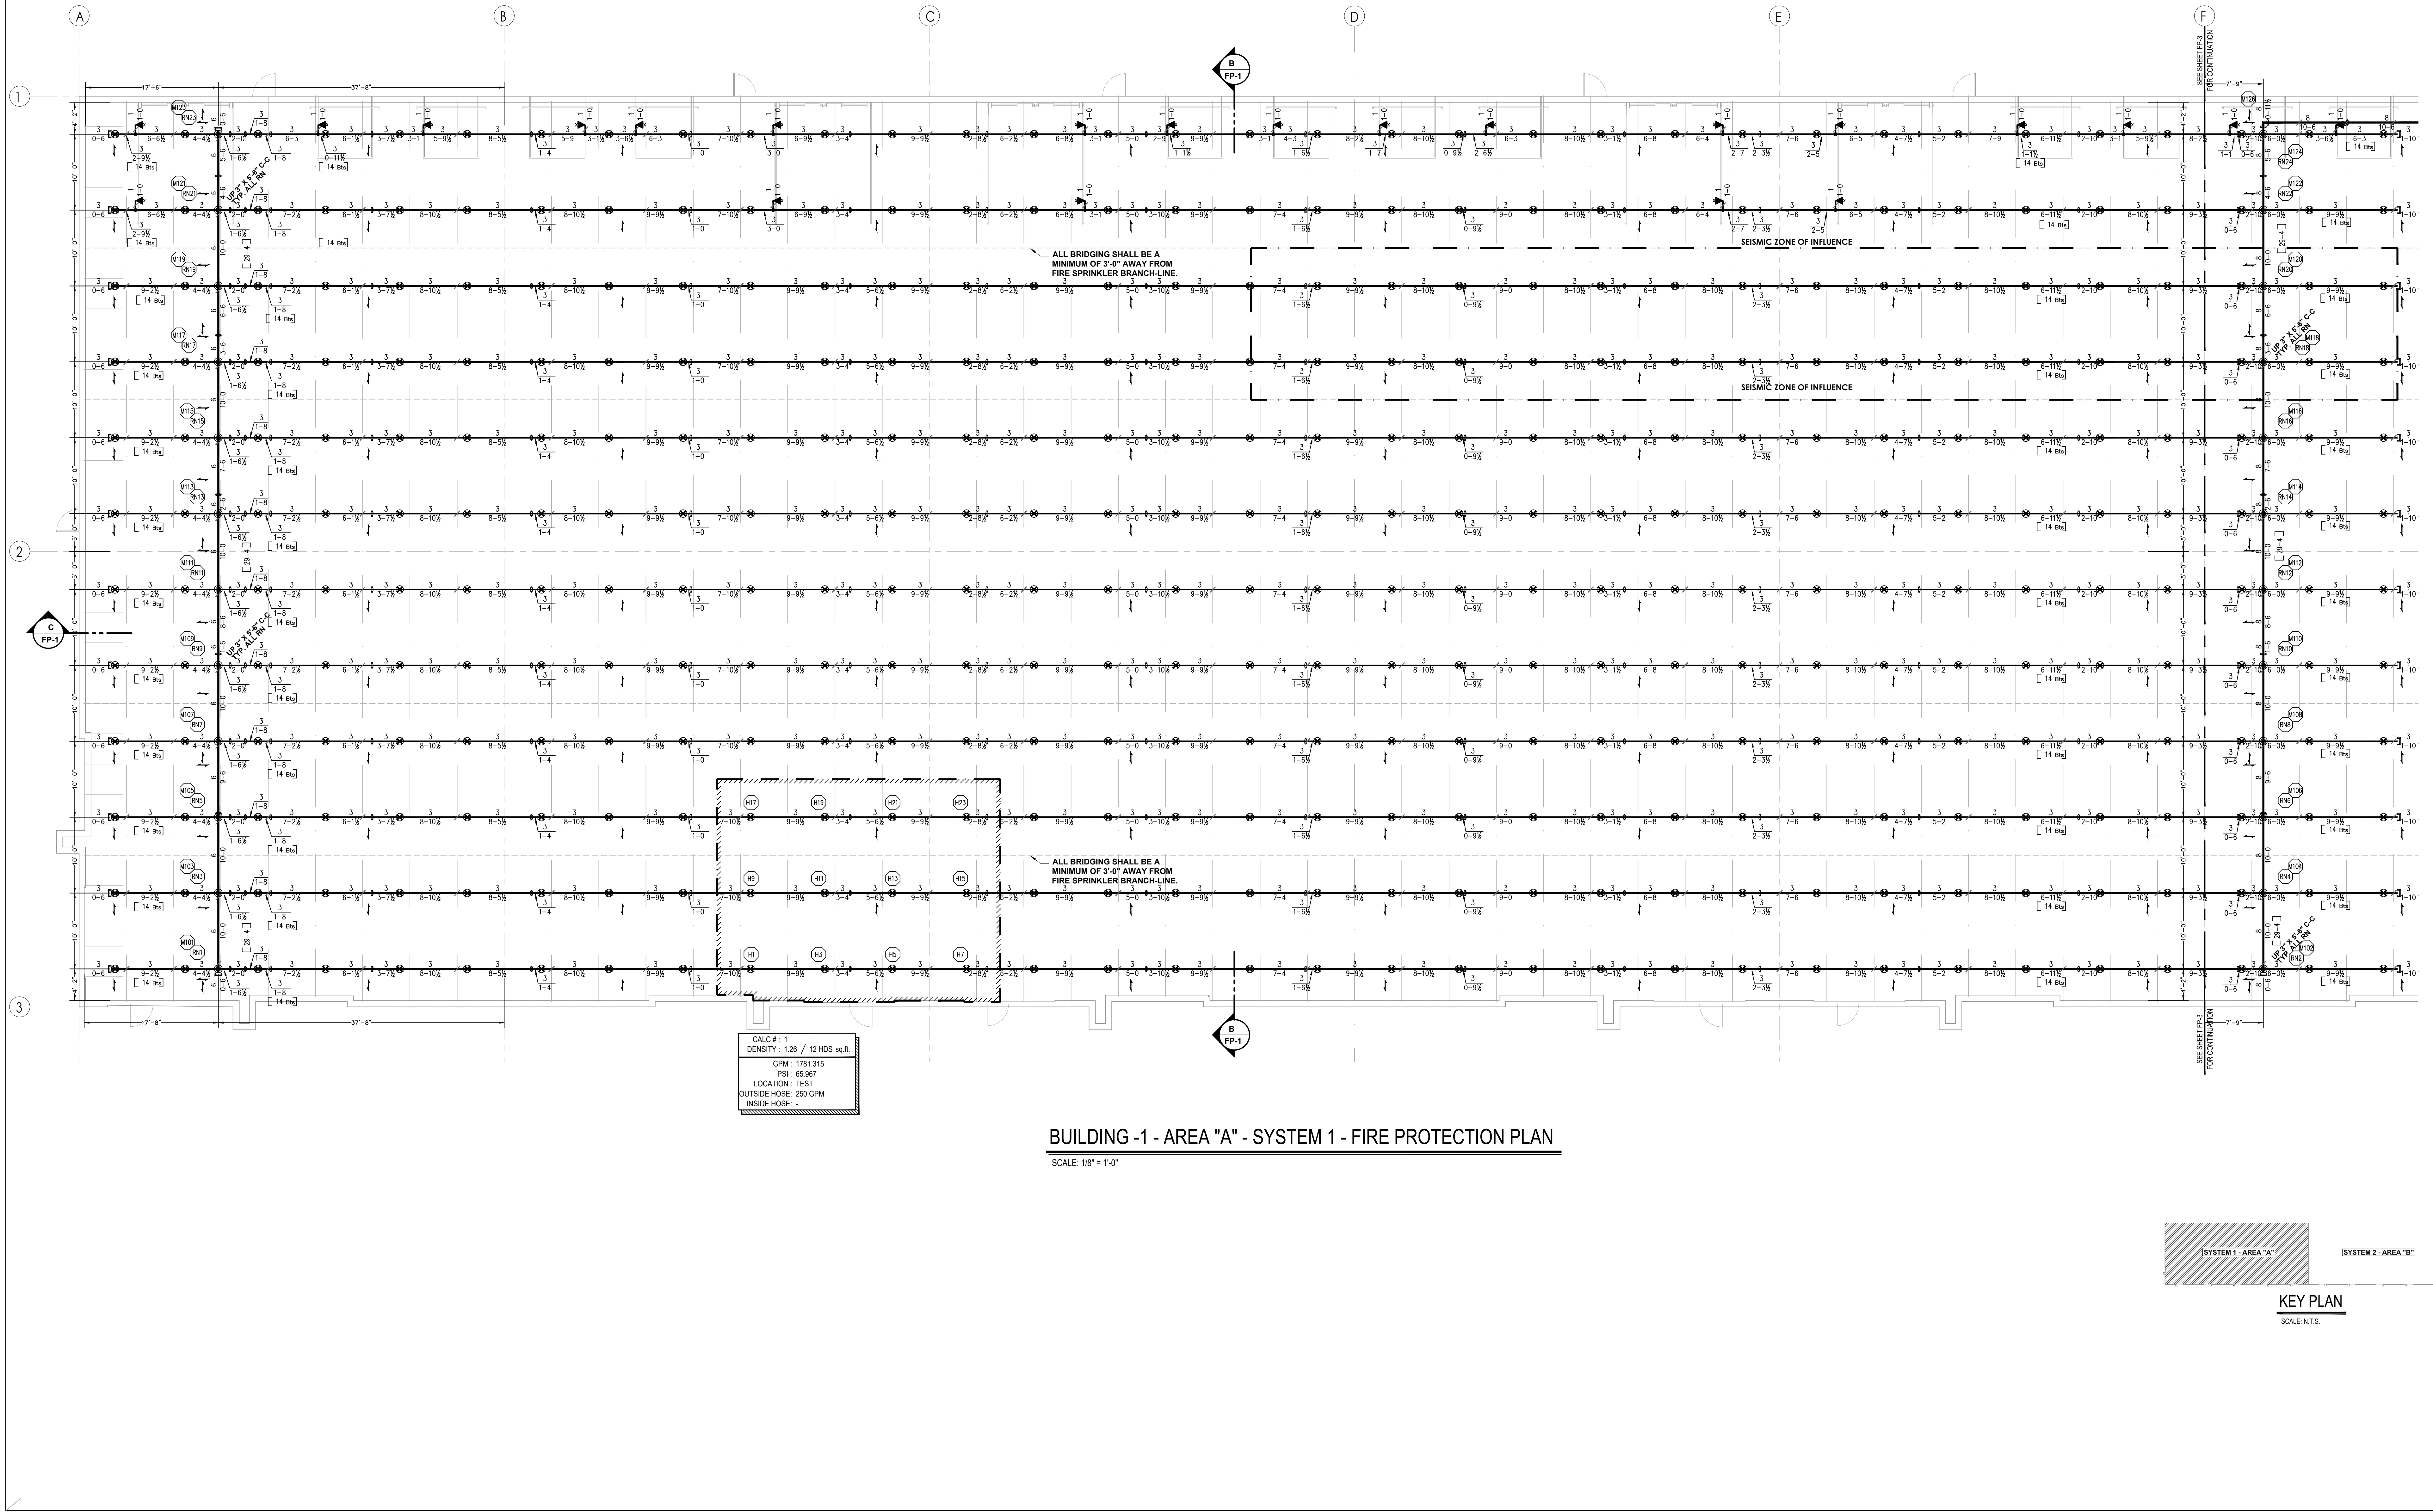

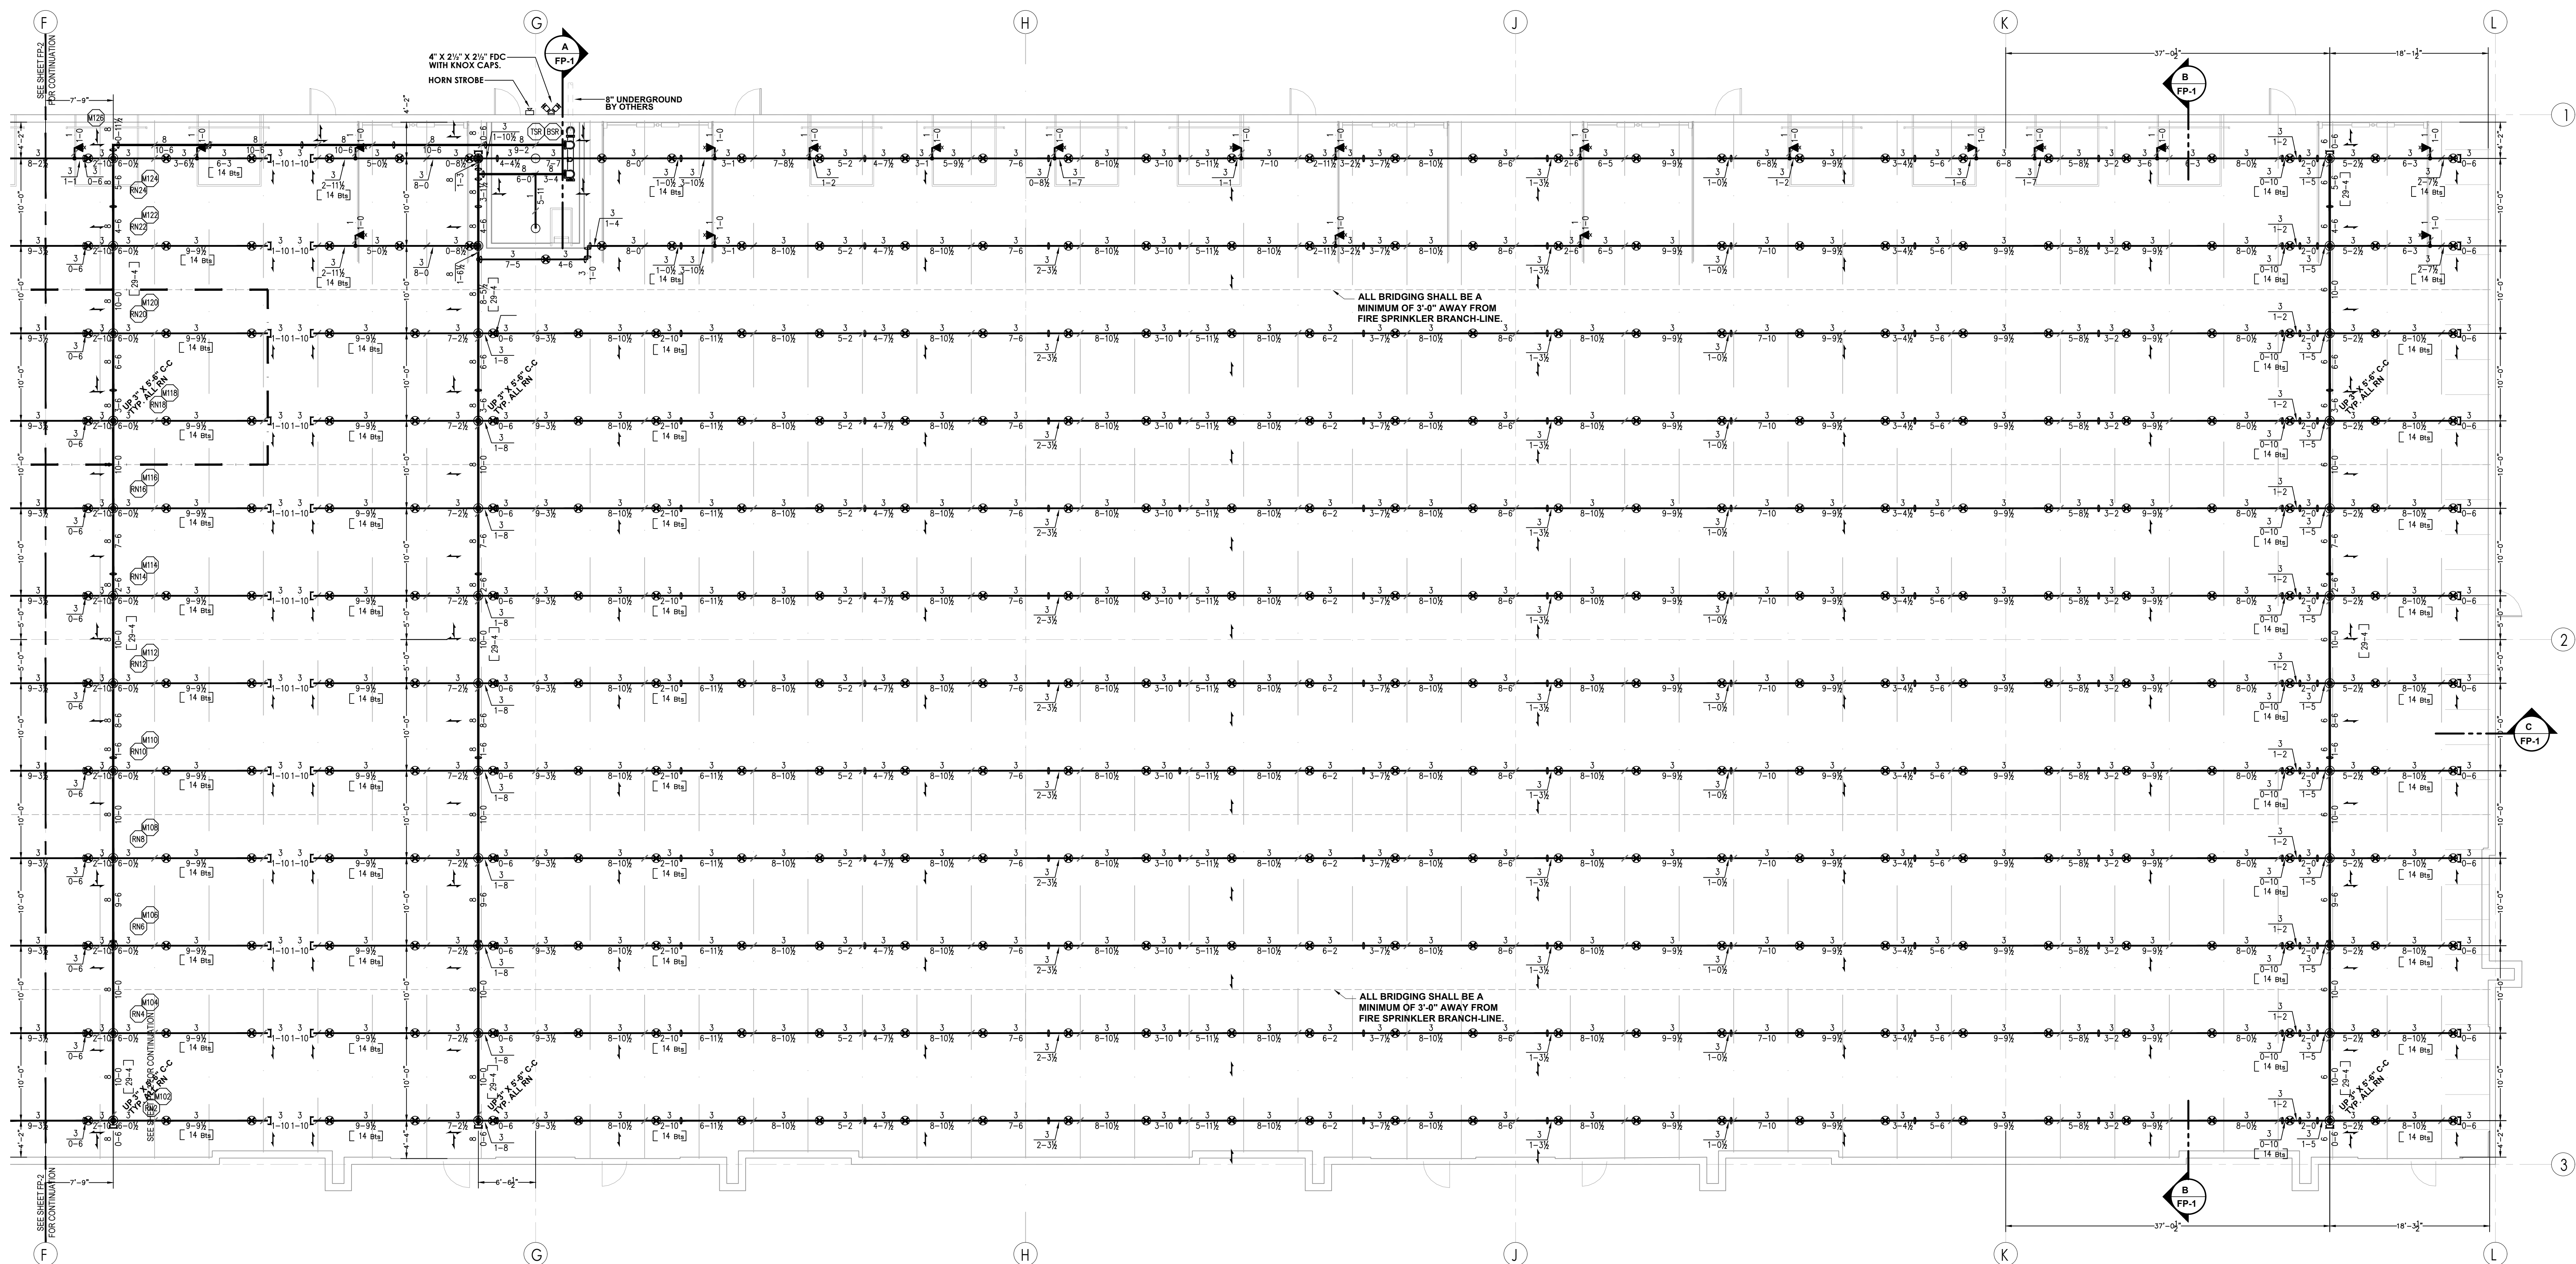

BUILDING - 1 - AREA "B" - SYSTEM 2 - FIRE PROTECTION PLAN
SCALE: 1/8" = 1'-0"

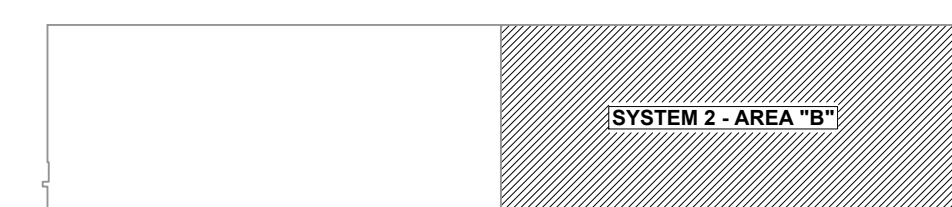

KEY PLAN